



LISTE MEUBLES/EQUIPEMENTS INSTALLATION

Numero	Nom de l'Article	Qte
M1	Casework Base Single Door 2	2
M2	Casework Base W/ Double Doors and Drawers	2
M3	Base Cabinet with 4 Drawers	1
M4	Wall Upper Cabinet With Double Doors - 36"	2
M5	Wall Upper Cabinet With Double Doors - 39"	1
M6	Tall Cabinet Single Door	1
M7	Wall Upper Cabinet with Double door - Glass Door	1
M8	Meuble Sous Lavabo - Double Porte - 900mm	1
M9	Base Cabinet Corner Unit Square - 36"	1
M10	Base Cabinet - End Sink Unit - 52"	1
D1	Speciality Equipement Refrigerateur - 695x660x1650mm	1
D2	Hotte de cuisine - 760 mmx300 mm	1
D3	Kitchen Cabinet Finsa - Pro Base Oven Unit - 640 x 500 x 872 mm	1
D4	Specialty Equipment Dishewasher - 580x600x850mm	1
D14	Washer Front Load - 27"	1
D15	Dryer Front Load - 27"	1

LISTE DES MATERAUX

Numero	Nom de l'Article	Qte
S1	Plancher de Bois Franc Marron tel que Bois Existant	501.5 ft2
S2	Sol de Ceramique - Blanc	283.5 ft2

LISTE MEUBLES AMENAGEMENT

Numero	Nom de l'Article	Qte
D5	Furniture Table 2000x1000x750mm_w-4_Seats	1
D6	Specialty Equipement TV - 1070mm_Diagonal	1
D7	Meuble TV - 1470 x 500 x 560 mm	1
D8	Sofa Cresnent - 1590x580x380mm	1
D9	Bureau - 1360 x 600 x 740 mm	1
D10	Chair Desk	1
D11	Furniture Bed - 1525x2007x355mm-Queen	1
D12	Table de Chevet Type 02 - 500 x 400 x 700 mm	2
D13	Armoire a deux porte Coulissante - 150 x 66 x 236 cm - Noir brillant	1


LISTE EQUIPEMENTS PLOMBERIE

Numero	Nom de l'Article	Qte
PL1	Sink - 450 x 450mm	1
PL2	Lavabo Mural - 1000mm x 400mm	1
PL3	Plumbing Fixture WC Cistern - 540x360x820mm	1
PL4	Plumbing Fixture Shower Tray Square - 1200x900mm	1
PL5	Plumbing Fixture Double Equal Sink Kitchen Square - 1000x535x230mm	1
PL6	Douche Mural type 02	1

LISTE DIVERS

Numero	Nom de l'Article	Qte
ME1	Ceiling Propeller Fan - 310 mm	1
E1	Electrical Panel	2
PL7	Chauffe-Eau Electrique - Vertical - 150 litres - D 505 mm	3

Montreal
H4B 1Y4
QC, CA

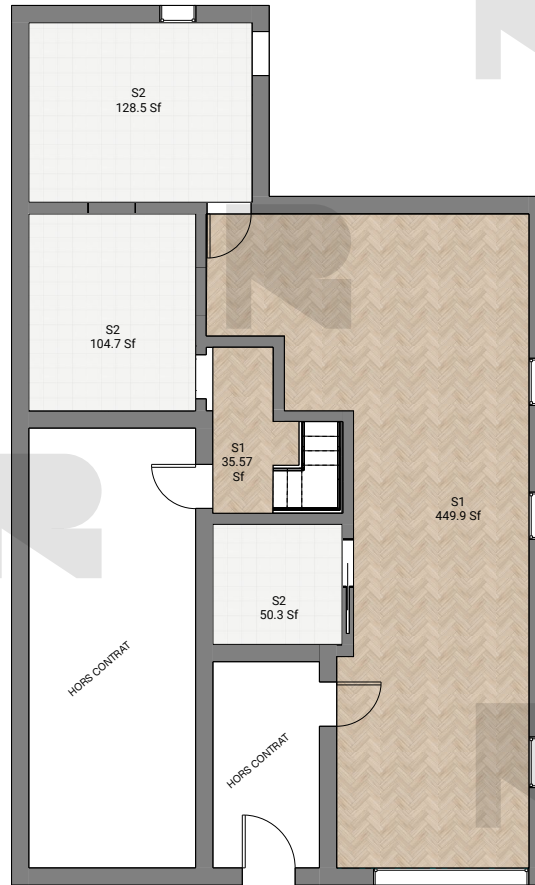

LEGEND:



Plancher de Bois Franc
Marron
Ceramique Blanche
Material: 12,7 mm x 6,5
po
Color: Marron (#042990)



Ceramique Blanche
Material: Ceramic Tile 60x60
Color: Blanche (#042990)
Quantity : 283.5 Sf

Notes :

Made by : William Kisuka

Date : 04/12/2024

Scale : 3/8" = 1'-0"



Project No : P001
Drawing No :

A01

Notes :

Made by : William Kisuka

Date : 04/12/2024

Scale : 3/8" = 1'-0"




Project No : P001
Drawing No :


A01

Montreal
H4B 1Y4
QC, CA

ZONAGE

- Bureau/
Chambre
- Couloir/
Escalier
- Cuisine
- Salle de
Bain
- Salle Lavage/
Rangement
- Salle
Mecanique
- Salon/Salle a
Manger

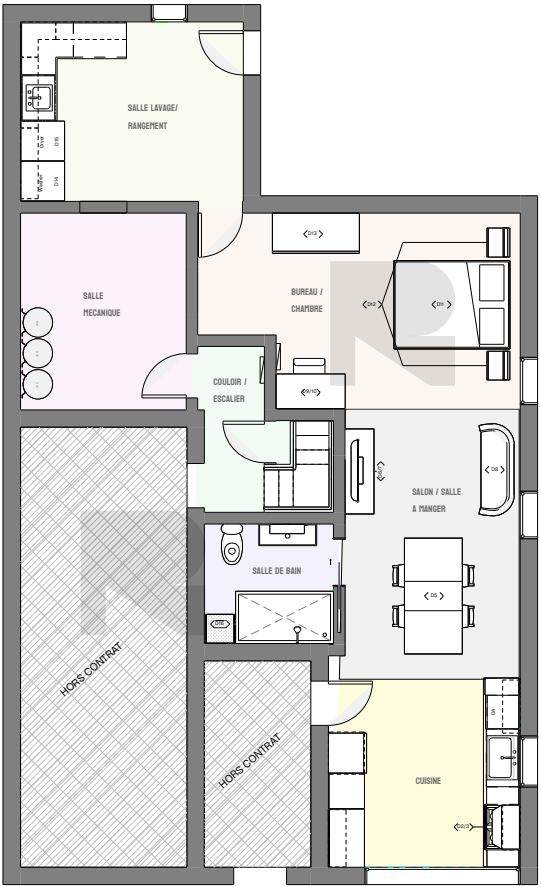

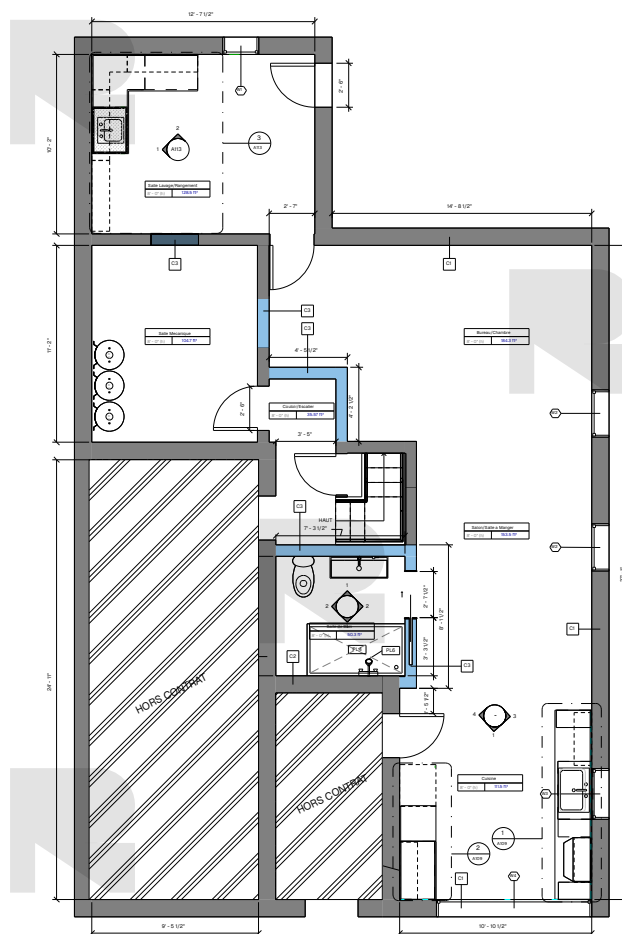

CLOISON TYPIQUE INT.

C1		- Mur existant - Colomages en bois - 2" x 4" @ 16" c/c - Laine isolante 3.5" - Gypse 1/2"
C2		- Mur existant - Colomages en bois - 2" x 4" @ 16" c/c - Laine isolante 3.5" - Gypse 1/2" hydrofuge
C3		- Colomages en bois - 2" x 4" @ 16" c/c - Gypse 1/2"
C4		- Colomages en bois - 2" x 4" @ 16" c/c - Laine isolante 3.5" - Gypse 1/2" hydrofuge

LEGENDE GRAPHIQUE

Notes:

Made by : William Kisuka


Date : 04/12/2024

Scale : $3/8" = 1'-0"$



Project No :	P001
Drawing No :	

A01

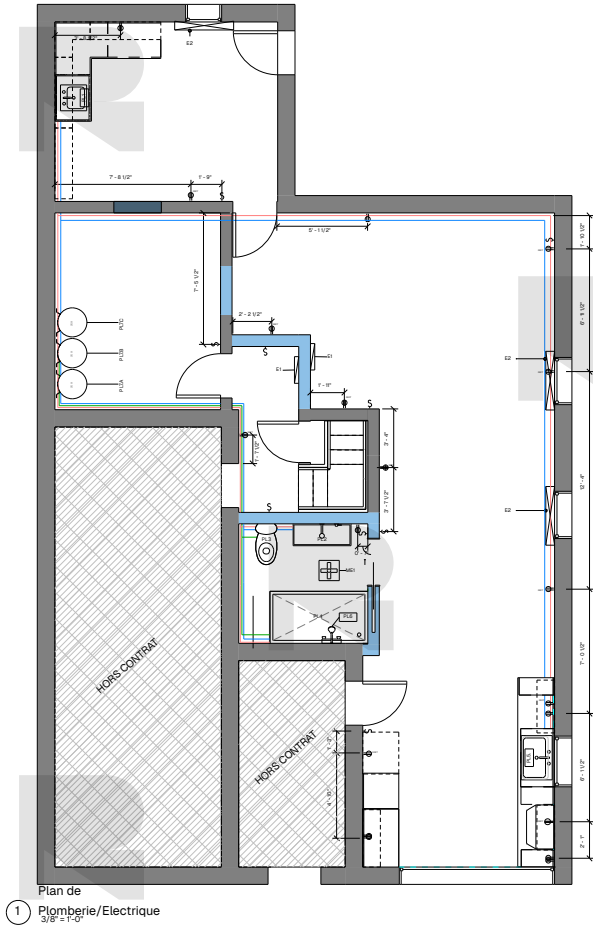

LEGENDE GRAPHIQUE

- Interrupteur (un bouton)
- Prise electrique Double
- Prise electrique Triple
- Prise electrique Double (Grounded)
- Prise electrique Triple (Grounded)
- Panel electrique
- Plinthe electrique
- Tuyau/Flux d'Eau Froide
- Tuyau/Flux d'Eau Chaude
- Tuyau de circulation d'eau recupere

Notes :

Made by : William Kisuka


Date : 04/12/2024

Scale : 3/8" = 1'-0"



Project No : P001
Drawing No :

A01

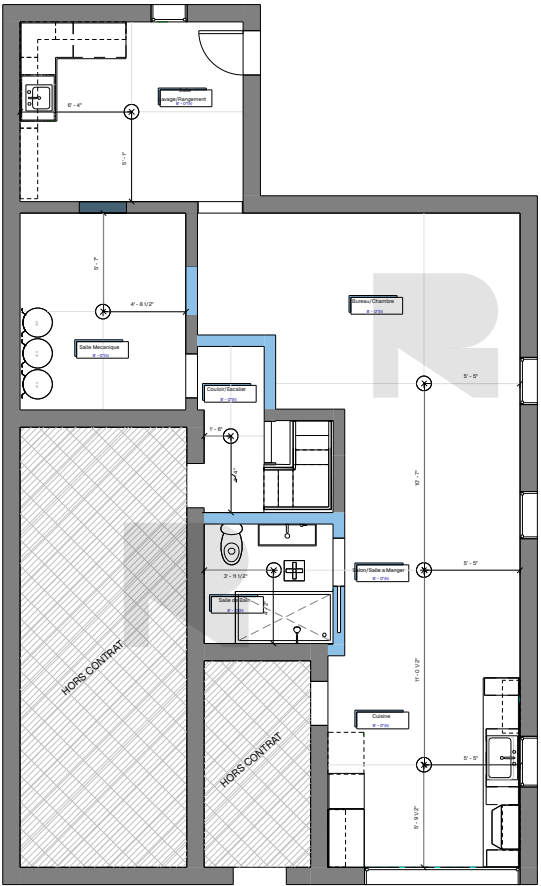

LEGENDE GRAPHIQUE

- Lumiere Plafonnier
- ⊞ Ventilateur Mecanique Plafonnier

Notes :

Made by : William Kisuka

Date : 04/12/2024

Scale : 3/8" = 1'-0"



Project No : P001
Drawing No :

A01

Notes :

Made by : William Kisuka


Date : 04/12/2024

Scale : 3/8" = 1'-0"




Project No : P001
Drawing No :

A01

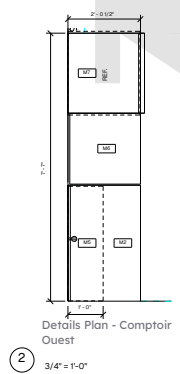


Details Plan - Comptoir Ouest

② 3/4" = 1'-0"

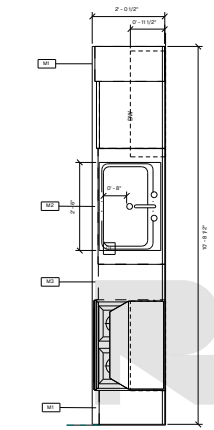


Details Plan - Comptoir Est

① 3/4" = 1'-0"

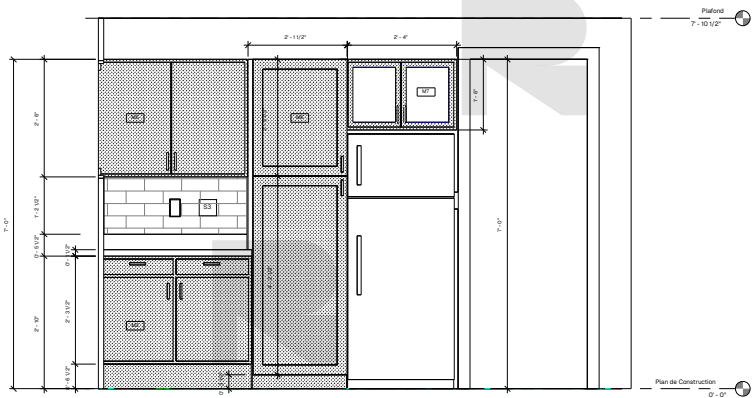

④ Elévation Cuisine - Ouest

1" = 1'-0"

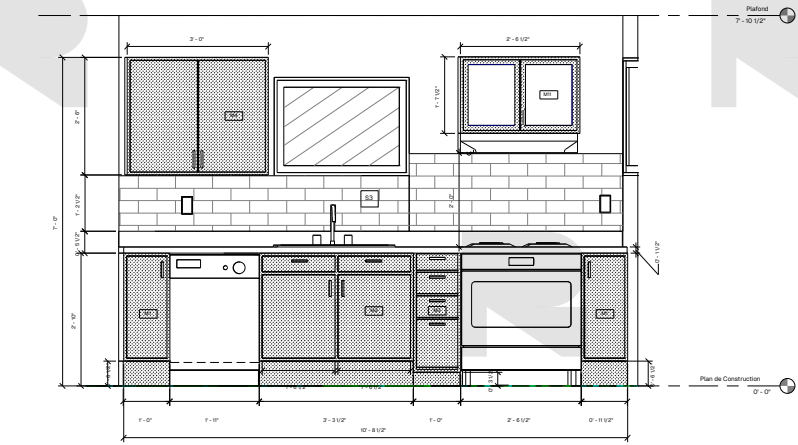

③ Elévation Cuisine - Est

1" = 1'-0"

Notes :

Made by : William Kisuka


Date : 04/12/2024

Scale : 3/8" = 1'-0"




Project No : P001
Drawing No :

A01

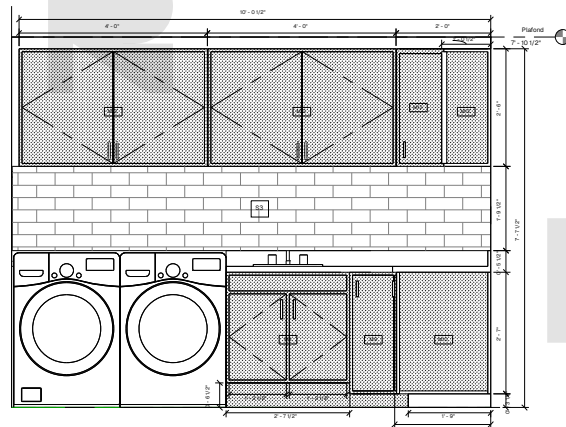


1 Elévation S.Lavage - 1
1" = 1'-0"

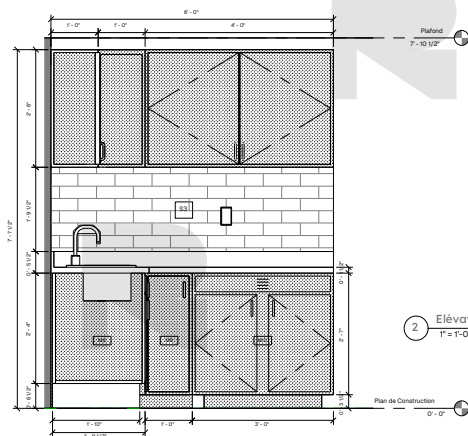

2 Elévation S.Lavage - 2
1" = 1'-0"

Plan de Construction
0'-0"

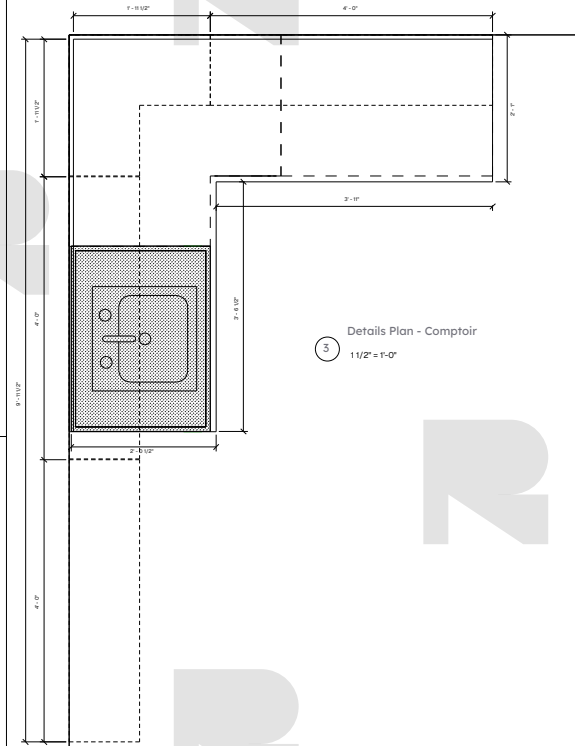

3 Details Plan - Comptoir
1 1/2" = 1'-0"

Notes :

Made by : William Kisuka



Date : 04/12/2024

Scale : 3/8" = 1'-0"



Project No : P001
Drawing No :

A01

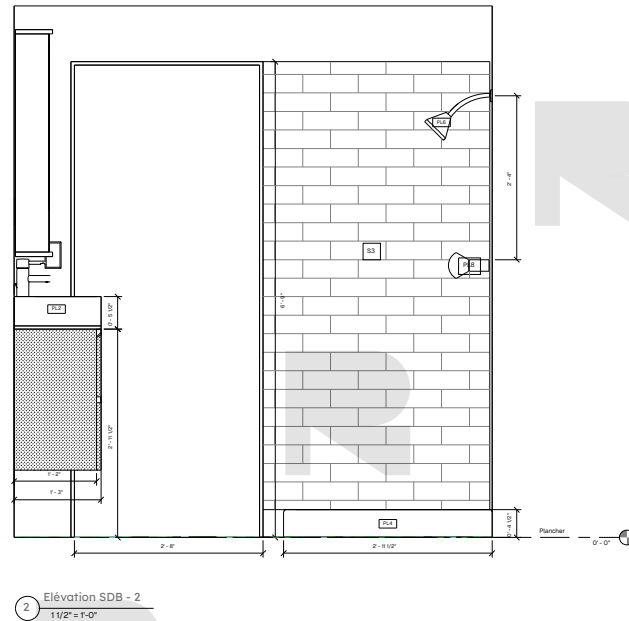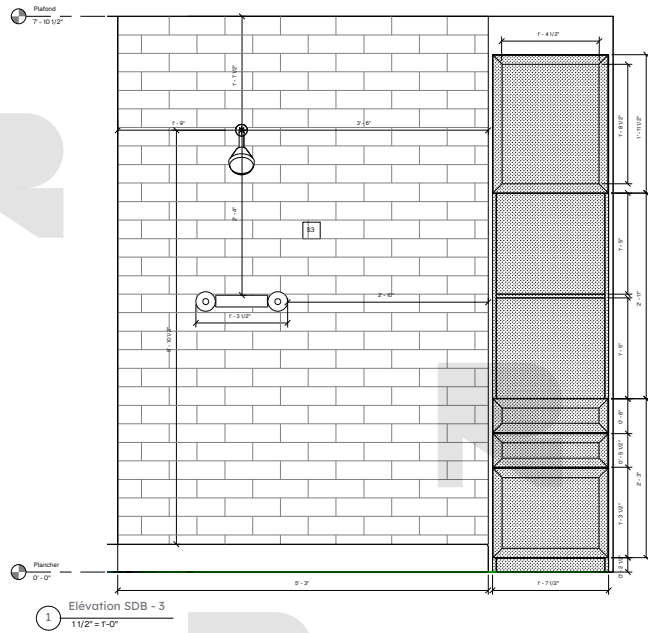

Notes :

Made by : William Kisuka



Date : 04/12/2024


Scale : 3/8" = 1'-0"




Project No : P001
Drawing No :

A01

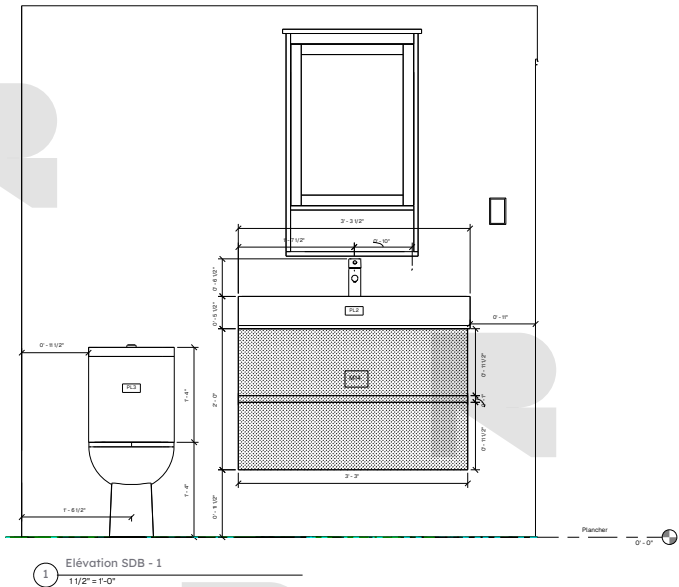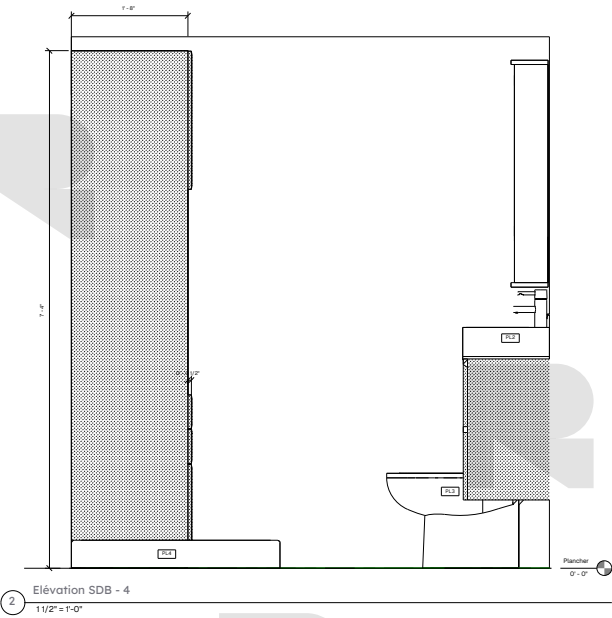


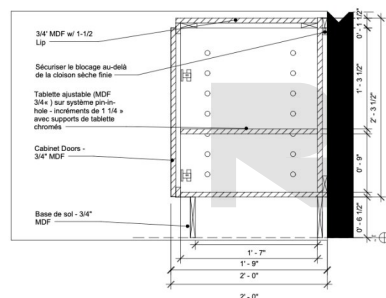


1 Details - Cuisine M1
1 1/2" = 1'-0"

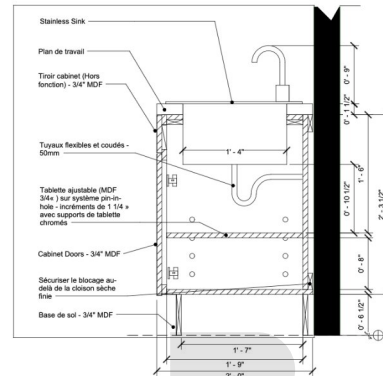


2 Details - Cuisine M2 Evier
1 1/2" = 1'-0"

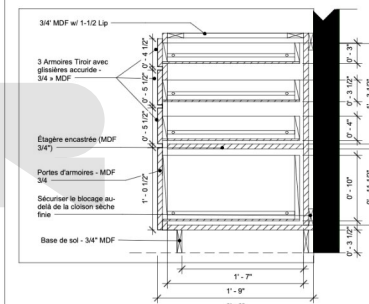


4 Details - Cuisine M3
1 1/2" = 1'-0"

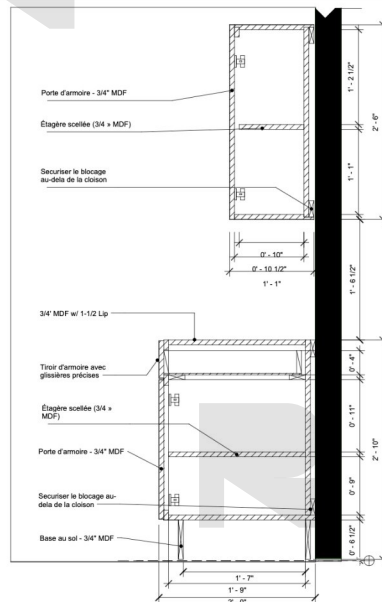

3 Details - Cuisine M2/M4.M5
1 1/2" = 1'-0"

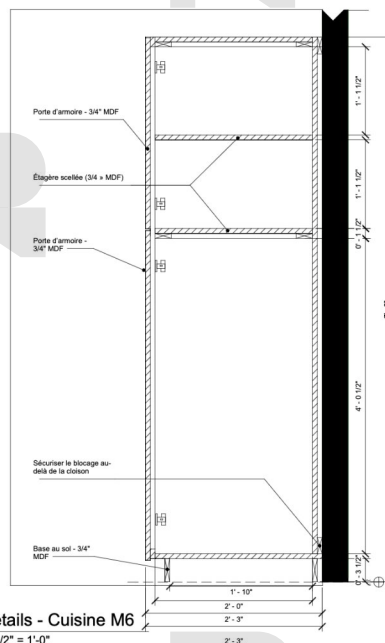

5 Details - Cuisine M6
1 1/2" = 1'-0"

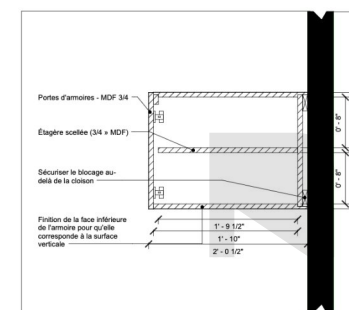

6 Details - Cuisine M7
1 1/2" = 1'-0"

Notes :

Made by : William Kisuka

Date : 04/12/2024

Scale : 3/8" = 1'-0"



Project No : P001
Drawing No :

A01